



REAR ELEVATION

SCALE: 1/4" = 1'0"

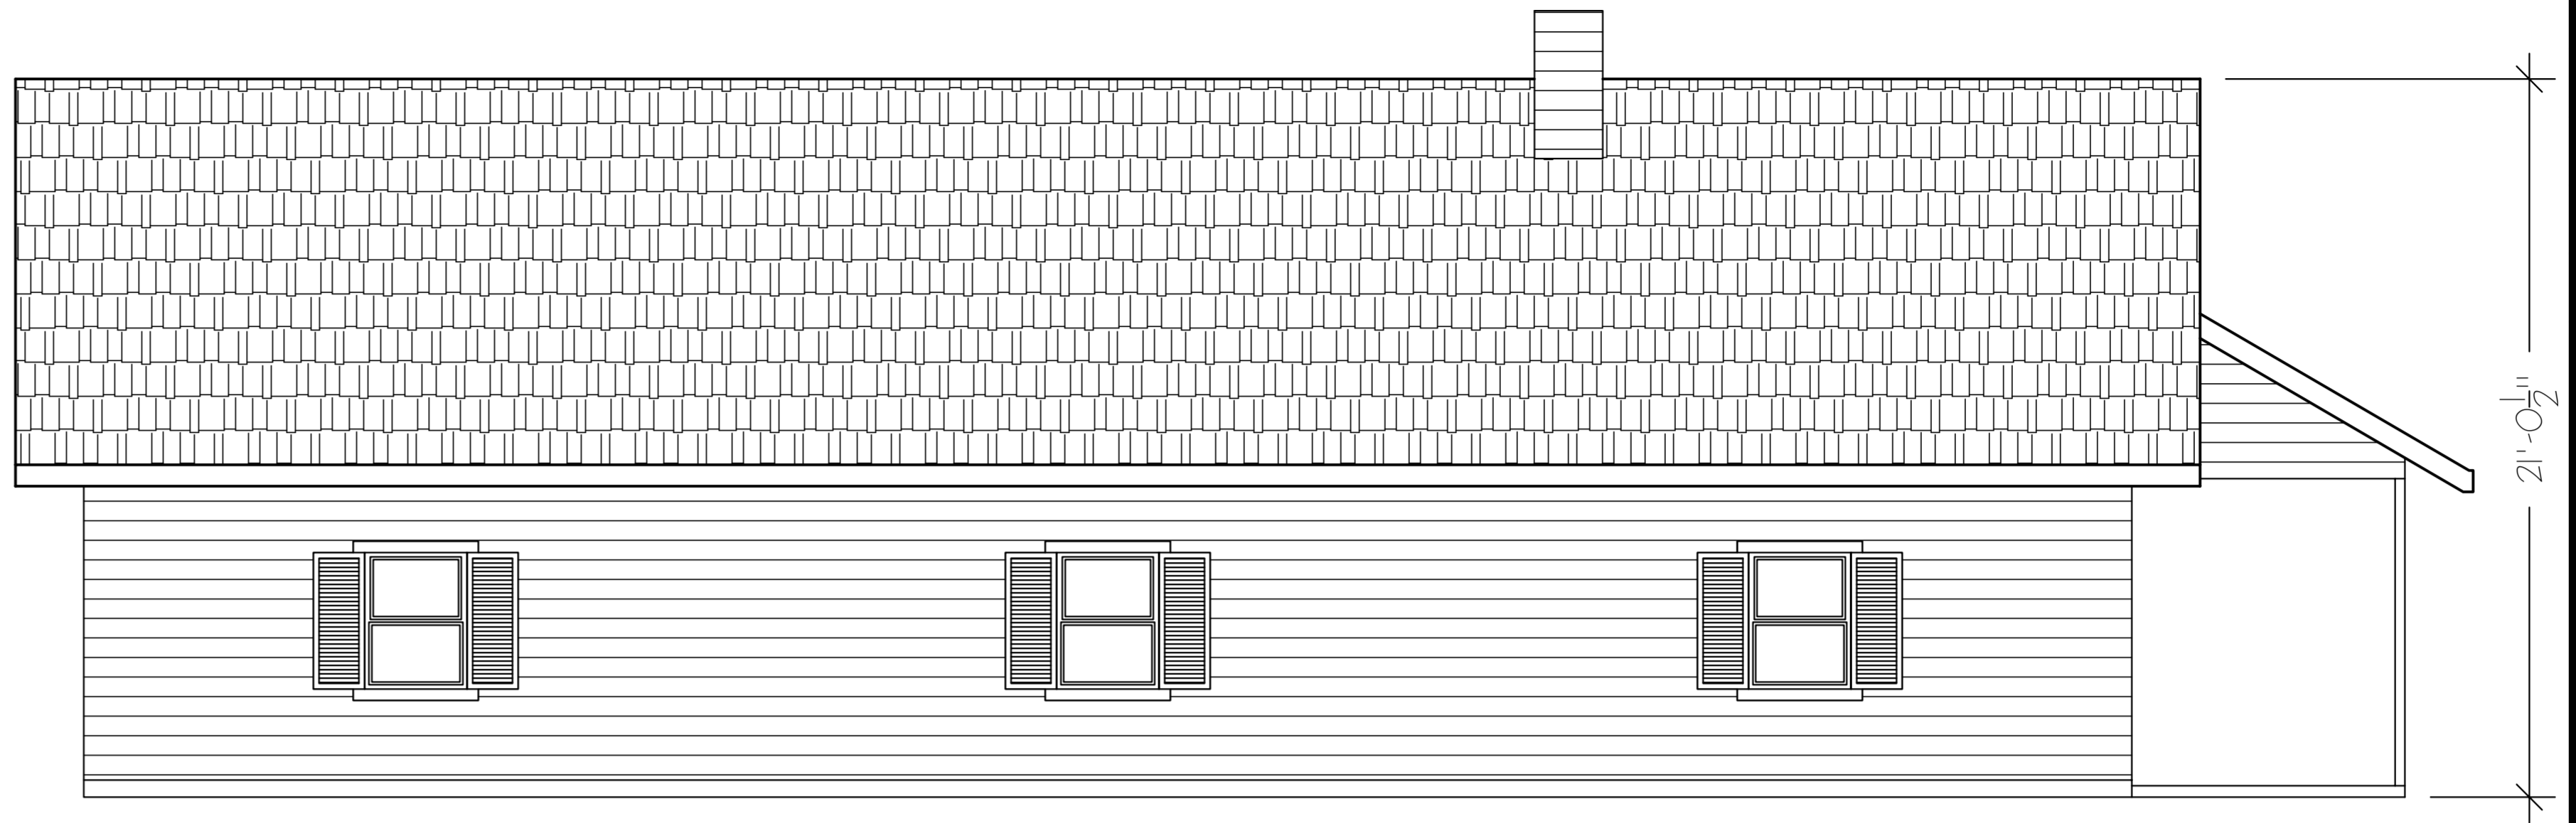


RIGHT SIDE ELEVATION

SCALE: 1/4" = 1'0"

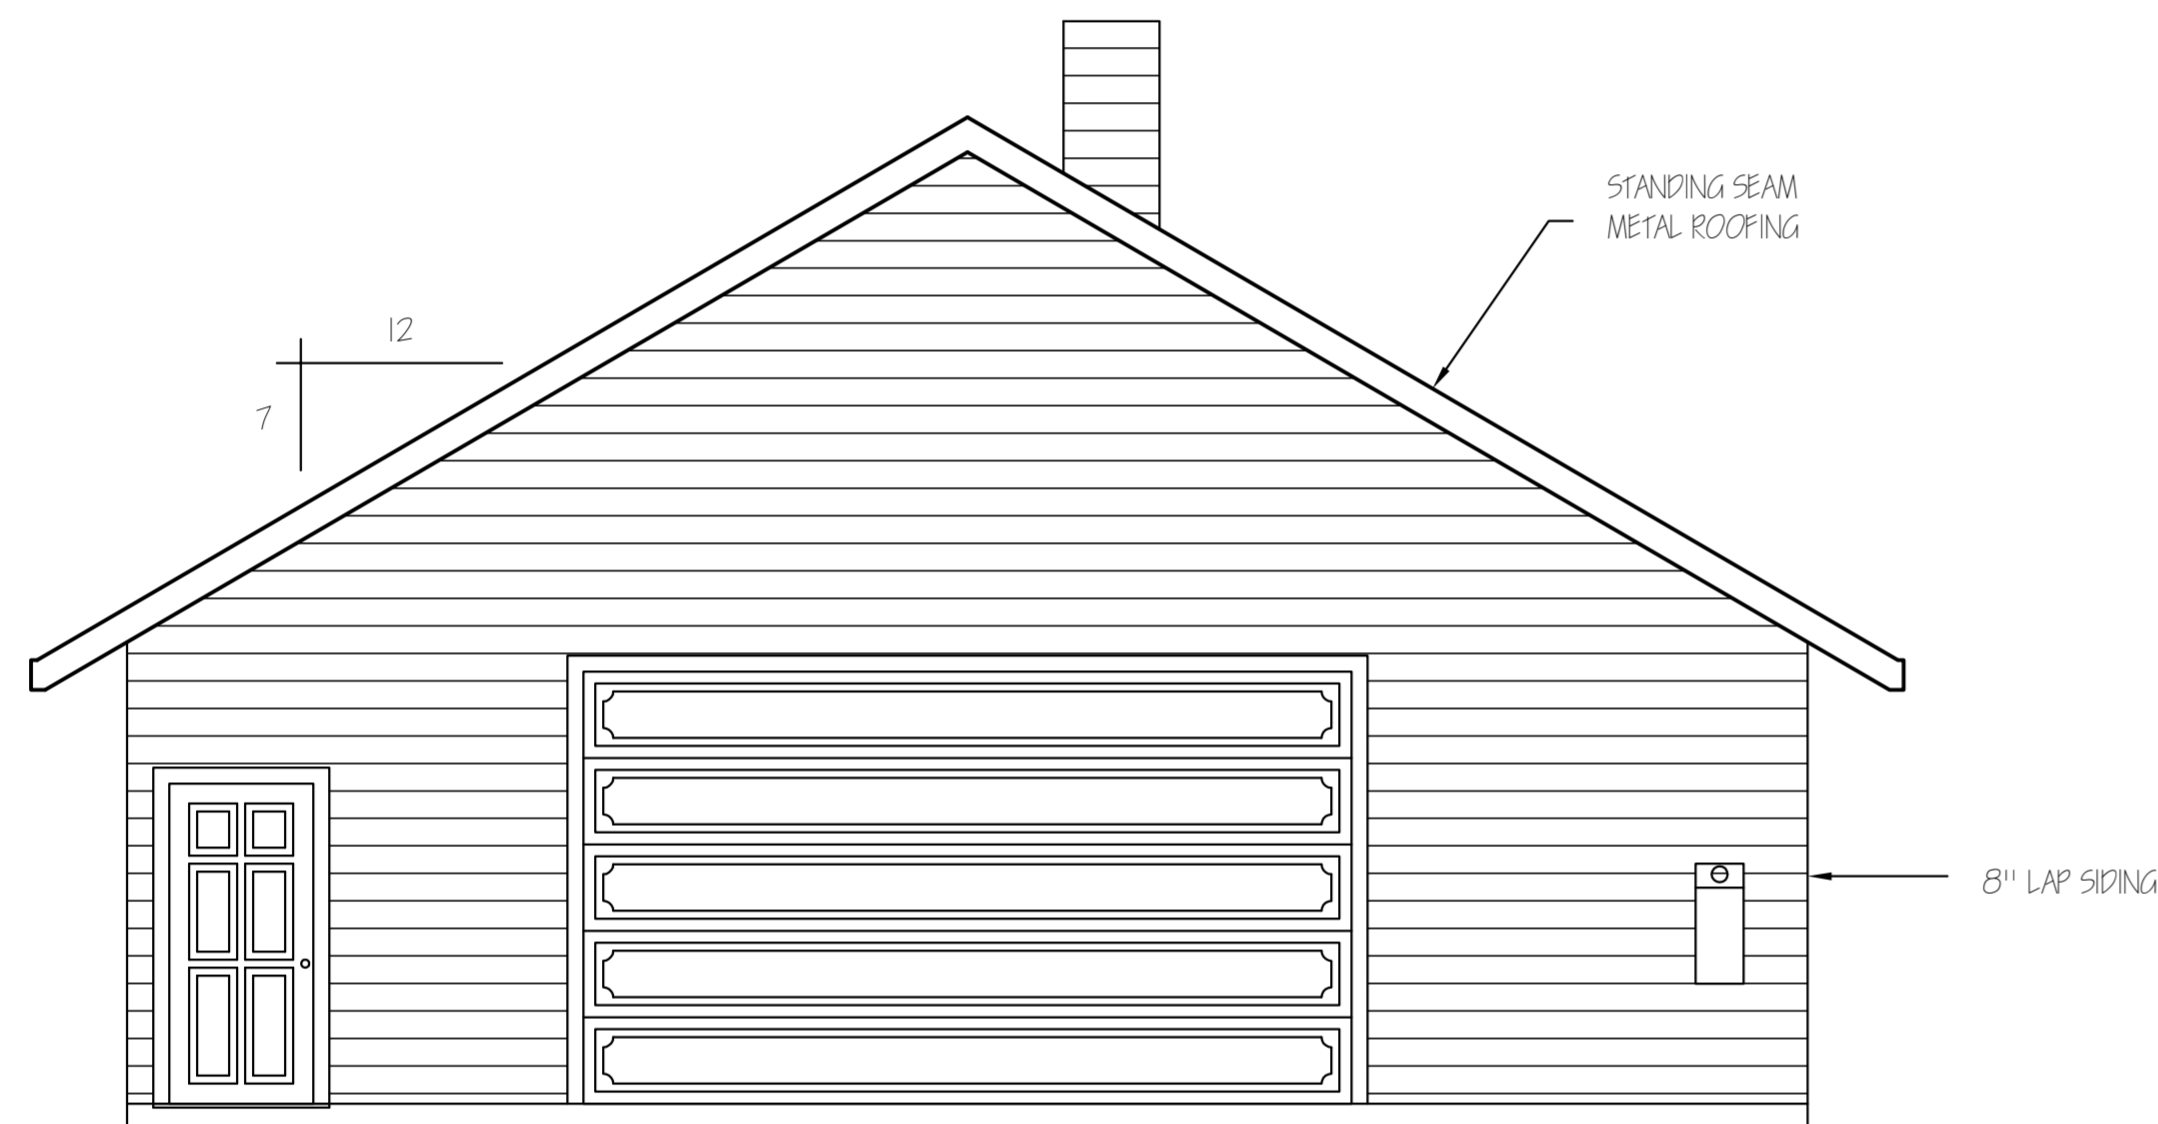


FRONT ELEVATION

SCALE: 1/4" = 1'0"

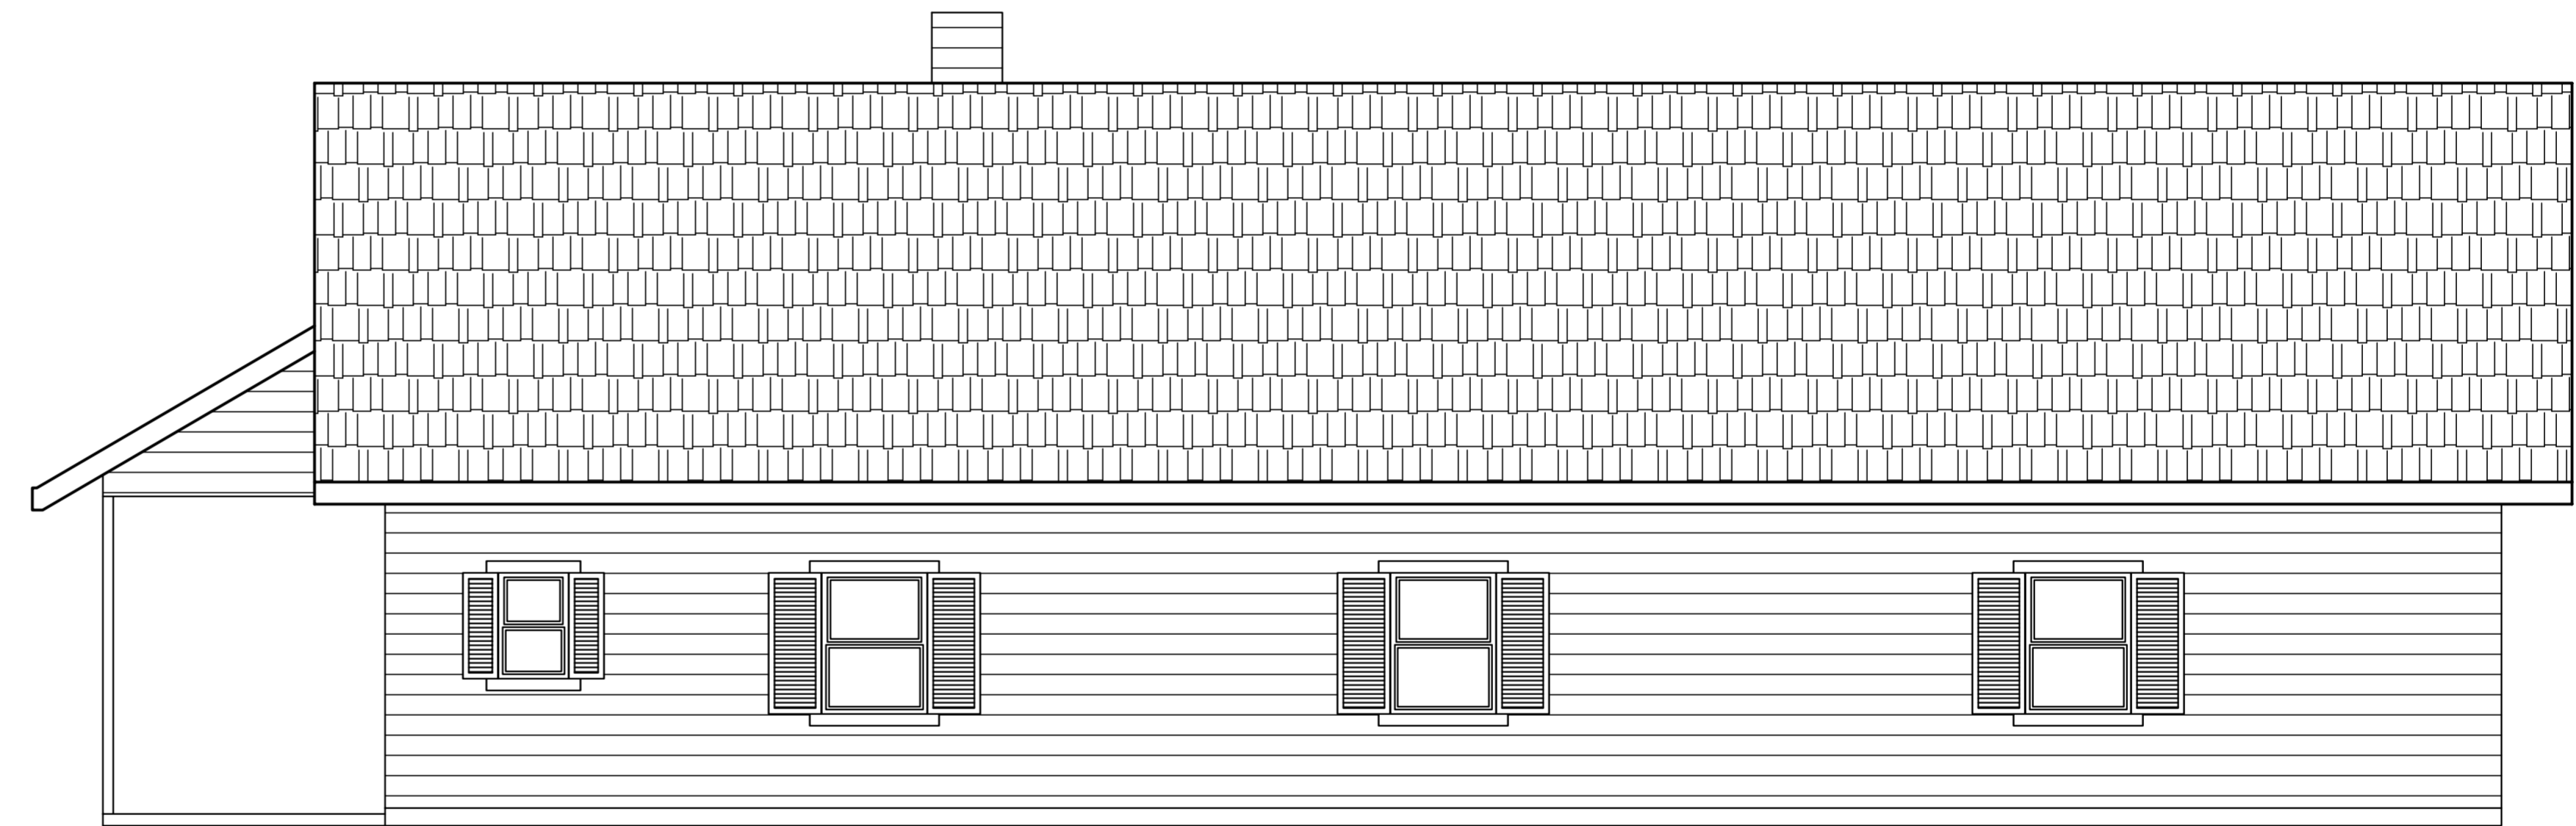

LEFT SIDE ELEVATION

SCALE: 1/4" = 1'0"

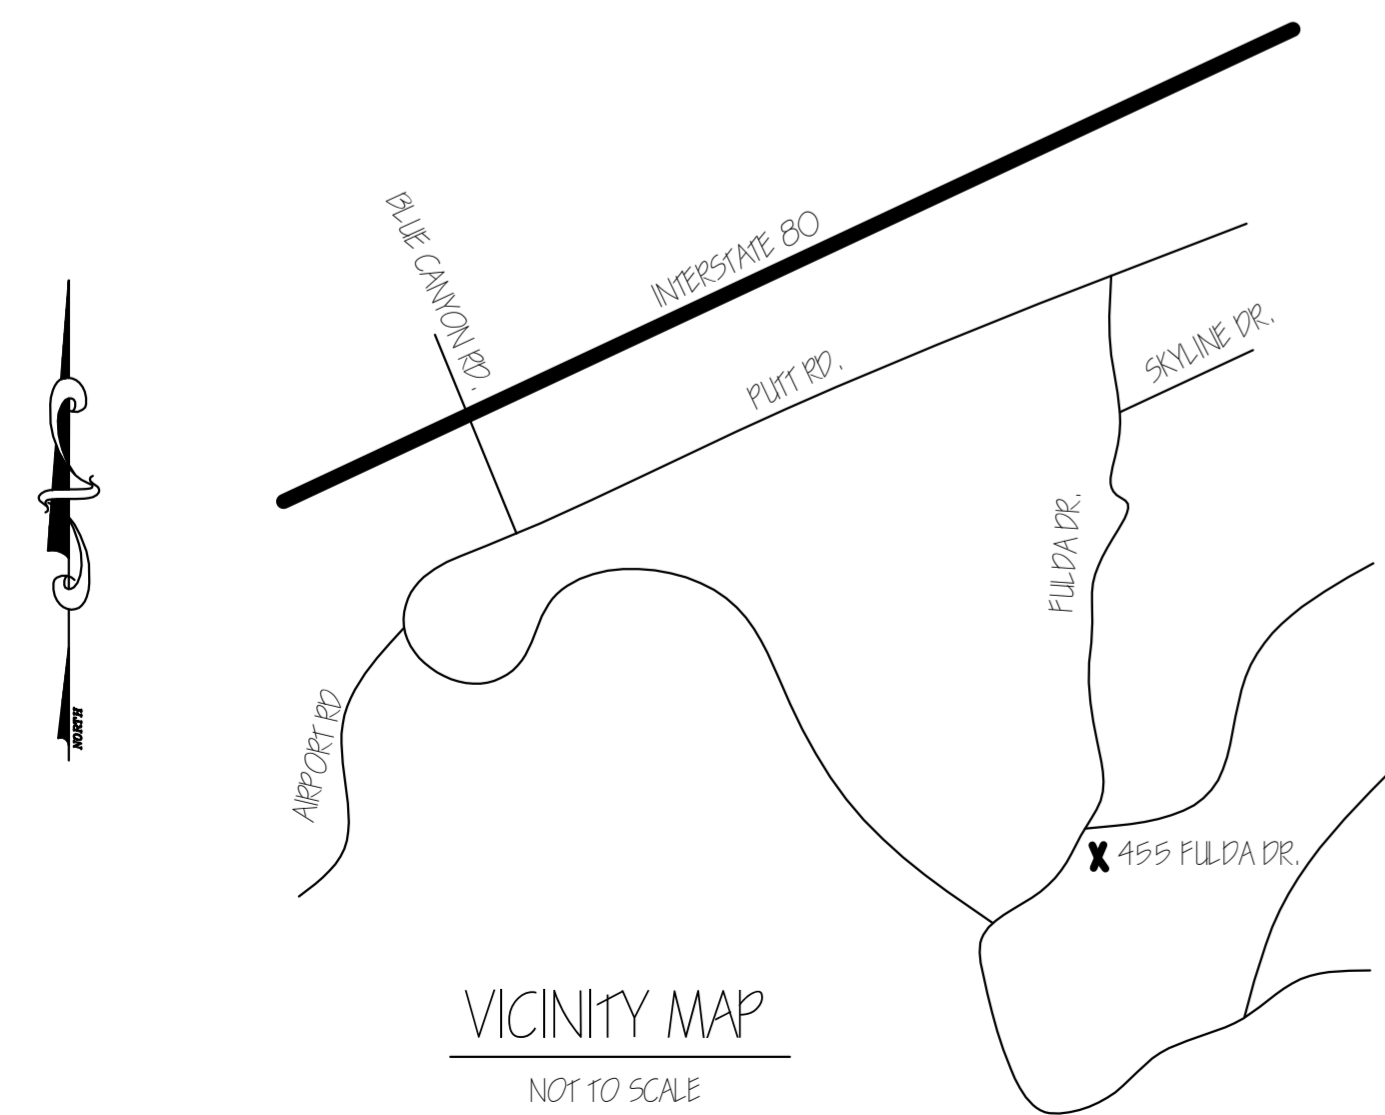

VICINITY MAP

NOT TO SCALE

DESIGN CRITERIA	
ROOF LIVE LOAD:	166 PSF (MIN. SNOW LOAD)
BASIC WIND SPEED:	85 MPH
EXPOSURE:	C
SEISMIC DESIGN CATEGORY:	D
SITE CLASS:	D
FLOOD DESIGN DATA:	N/A

TITLE 24 REQUIREMENTS	
WALLS:	R-19
ATTIC:	R-38
DUCTS:	N/A
FURNACE:	N/A
AC Split:	N/A
INSTANTANEOUS GAS WATER HEATER	
RADIANT BARRIER REQ'D IN ATTIC	

SCOPE OF PROJECT for Mrs. Sutton:  
1419 Sq. Ft. UNFINISHED BARN, 681 Sq. Ft. GAME ROOM

TABLE OF CONTENTS:

- SHEET # 1 - ELEVATIONS, SCOPE, VICINITY MAP
- SHEET # 2 - FLOOR PLAN & NOTES
- SHEET # 3 - ELECTRICAL PLAN & NOTES
- SHEET # 4 - FOUNDATION PLAN & NOTES
- SHEET # 5 - CROSS-SECTIONS & DETAILS
- SHEET # 6 - ROOF PLAN
- SHEET # 7 - ADDITIONAL REQUIRED NOTES
- SHEET # 8 - TITLE 24 FORMS

PLEASE NOTE PLOT PLAN PROVIDED BY OTHERS

VERIFY ALL DIMENSIONS ON SITE  
INFORMATION PROVIDED BY CONTRACTOR

Revisions

SCOPE OF PROJECT, VICINITY MAP  
AND ELEVATIONS

Robert, Skip, Weahunt  
California Contractors License # 351604  
4777 Sunrise Blvd, Suite A  
Fair Oaks, CA 95628

Proposed Team for:  
Mrs. Sutton  
455 Fulda Rd.  
Alta, CA 95701

Design & Drafting Services  
Kristin McCreagh  
(916) 316-4151  
draft@house@jalloo.com  
P.O. Box 7148705, Sacramento, CA 95871

Scale:

Noted

Date:

August 4, 2011

Job No.

2092

Sheet #1

of 8.